

© This drawing is Copyright. It should not be relied on or used in circumstances other than those for which it was originally prepared and for which 3D Land Surveys Ltd was originally commissioned. 3D Land Surveys Ltd accepts no responsibility for this drawing to any party other than the person(s) by whom it was commissioned.

NOTES

Survey Point Codes

- Air Value-Water AV
- Belisha Beacon BB
- British Telecom Cover BT
- Bollard BL
- Borehole BH
- British Telecom Box BX
- Bus Stop BS
- Cable CA
- Call Box CB
- CCTV CT
- Critical Level CL
- Cover - Unknown UC
- Down Pipe - Drainage DP
- Electricity Pole EP
- Floor Level FL
- Fire Hydrant FH
- Flag Staff FS
- Gas Valve GAS
- Grating GR
- Gully Grating-Drainage GU
- Inspection Cover-Drainage IC
- Inspection Cover-Electric EC
- Pipe Invert Level IL
- Kerb Outlet KO
- Lamp Post LP
- Letter Box LB
- Manhole Cover-Drainage MH
- Marker - MKR
- Mile Post MP
- Mile Stone MS
- Name Plate NP
- Pipe PI
- Post PO
- Pump PV
- Reflector/Road Post RP
- Rodding Eye RE
- Sign SI
- Sluice Valve-Water SV
- Soffit Level SL
- Stay Earth Wire SY
- Stop Tap-Water ST
- Top of Wall Tow
- Telegraph Pole TP
- Traffic Lights TL
- Water Meter WM
- Water Tap WT
- Vent Pipe VP

Survey to Ordnance Survey Grid & Level OSGB 36(15)

0	29/05/18	
REV	Date	NATURE OF REVISION

REVISIONS

3D Land Surveys Ltd

Ben Opie
 3D Land Surveys Ltd
 Reen Cottage, Reen Manor Farm
 Perranporth, Truro
 Cornwall TR6 0AJ
 www.3dlandsurveys.co.uk
 E mail: landsurveys3d@hotmail.co.uk

LOCATION

PROJECT
 28 Mount Wise
 Newquay
 Cornwall
 TR7

DRAWING TITLE
 Floor Plans


PROJECT MANAGER **Barron Surveying**

ORIGINATOR **Gus White**


SCALE
 1:100

DRAWING NO **1** REVISION **0**


Block 1
Lower Ground Floor

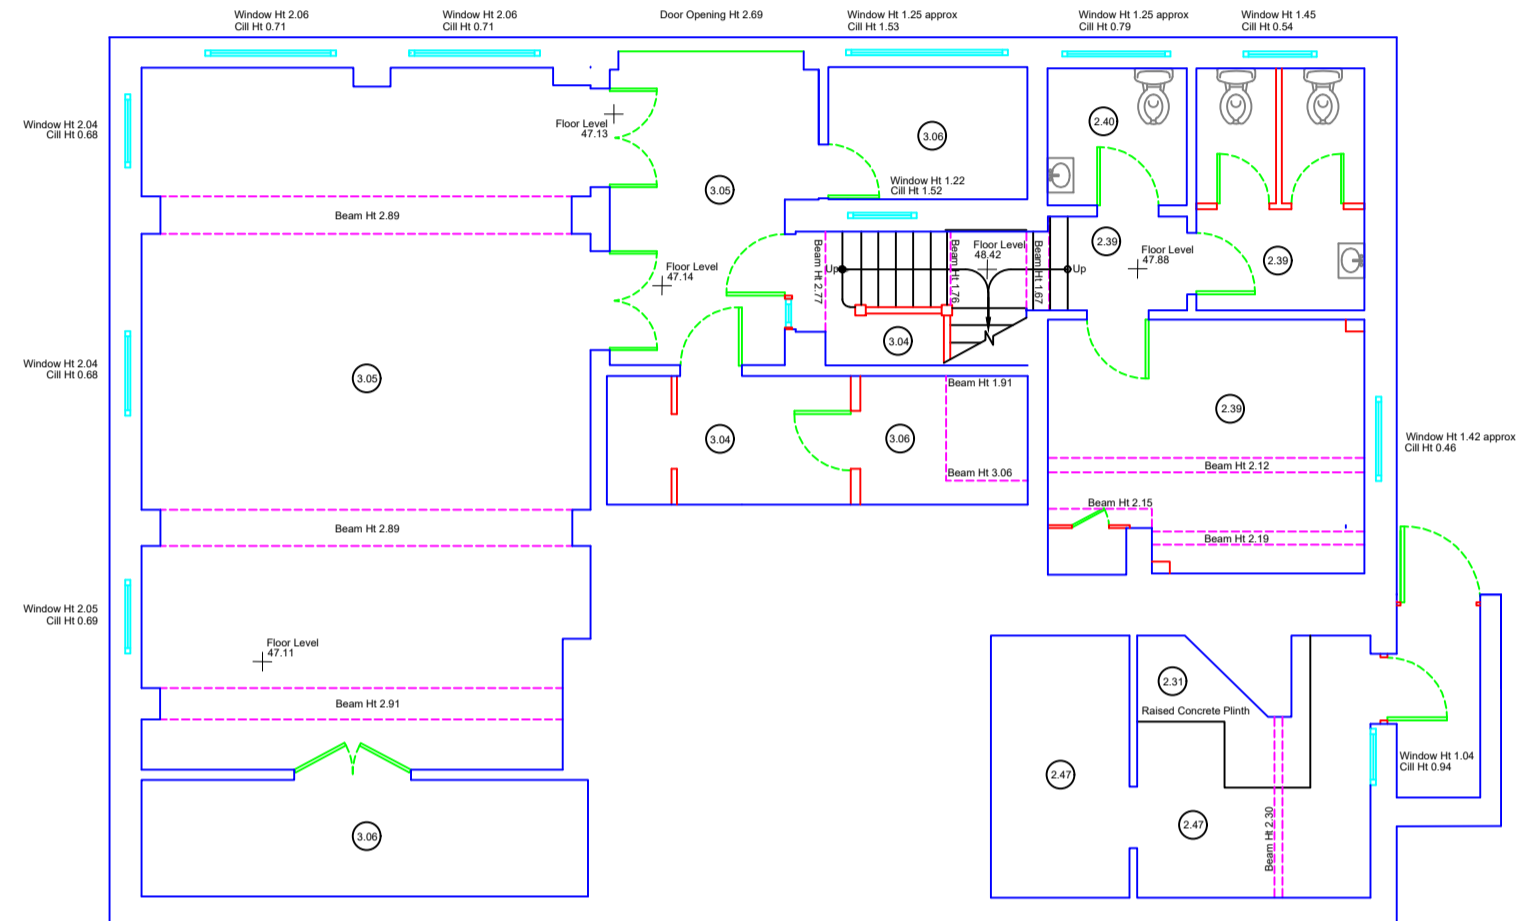


Block 1
Ground Floor

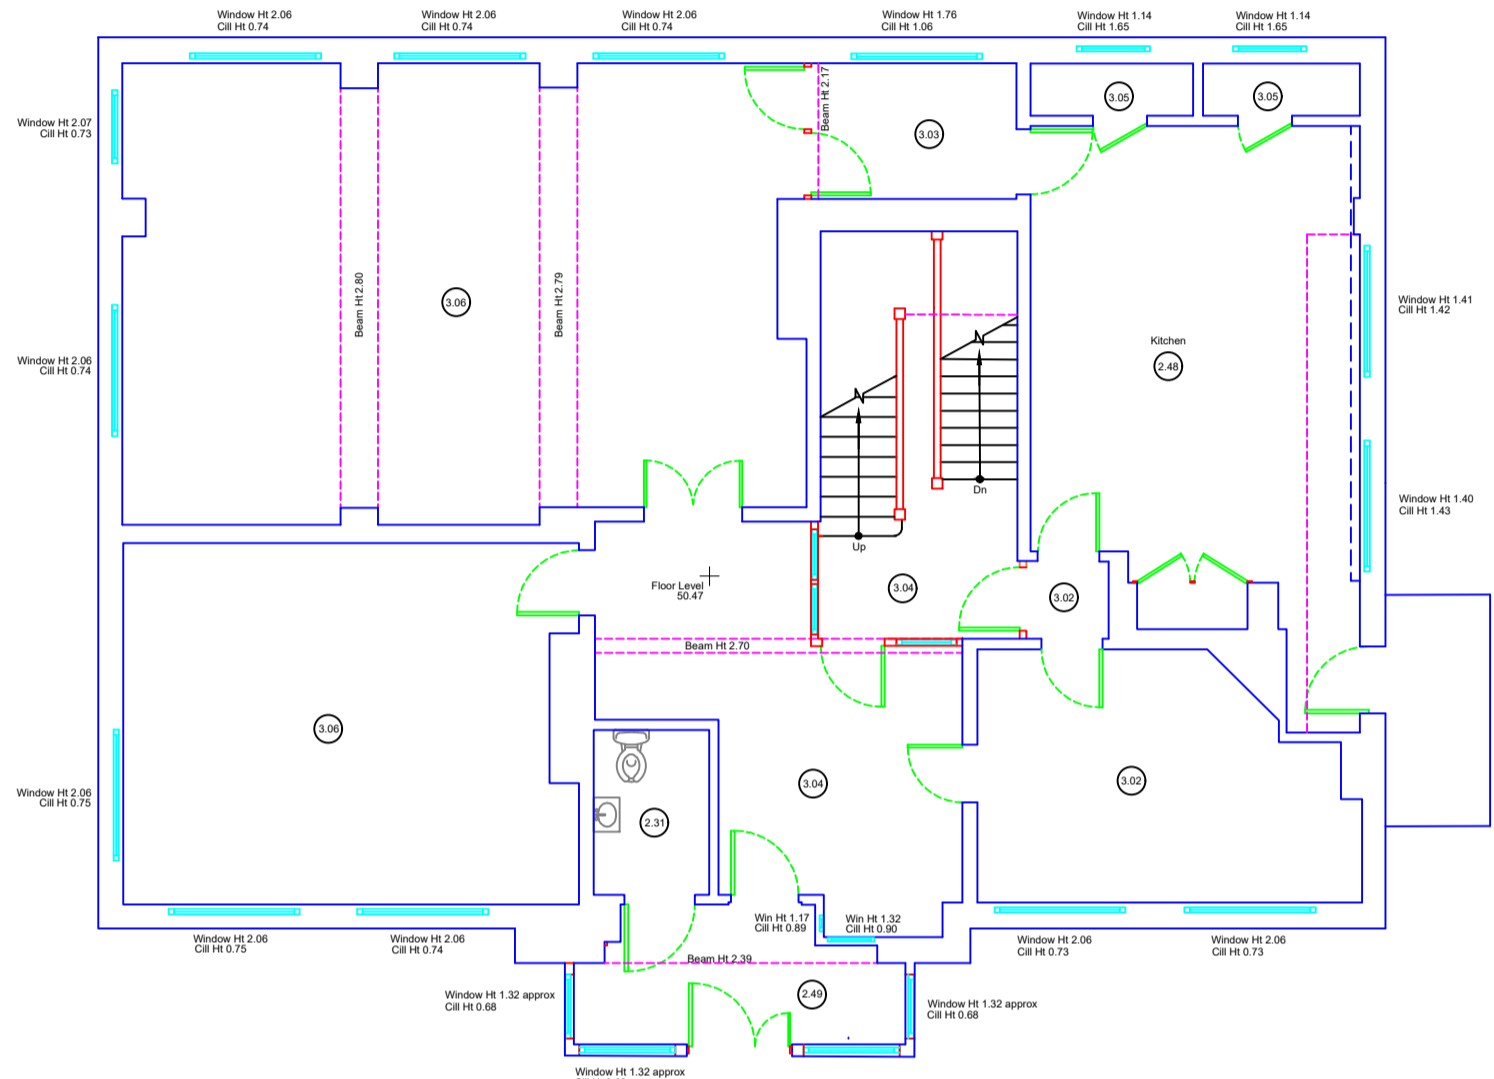


Block 2
Garage

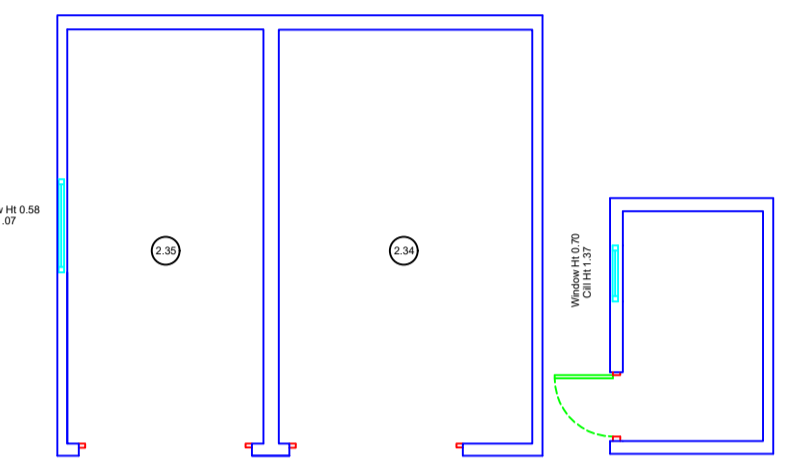

Block 3
Shed

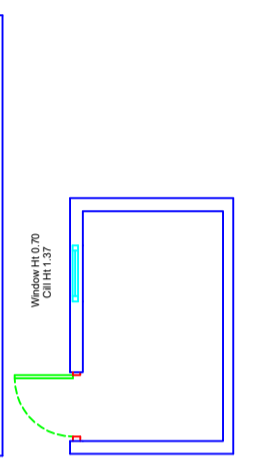

Block 1
First Floor

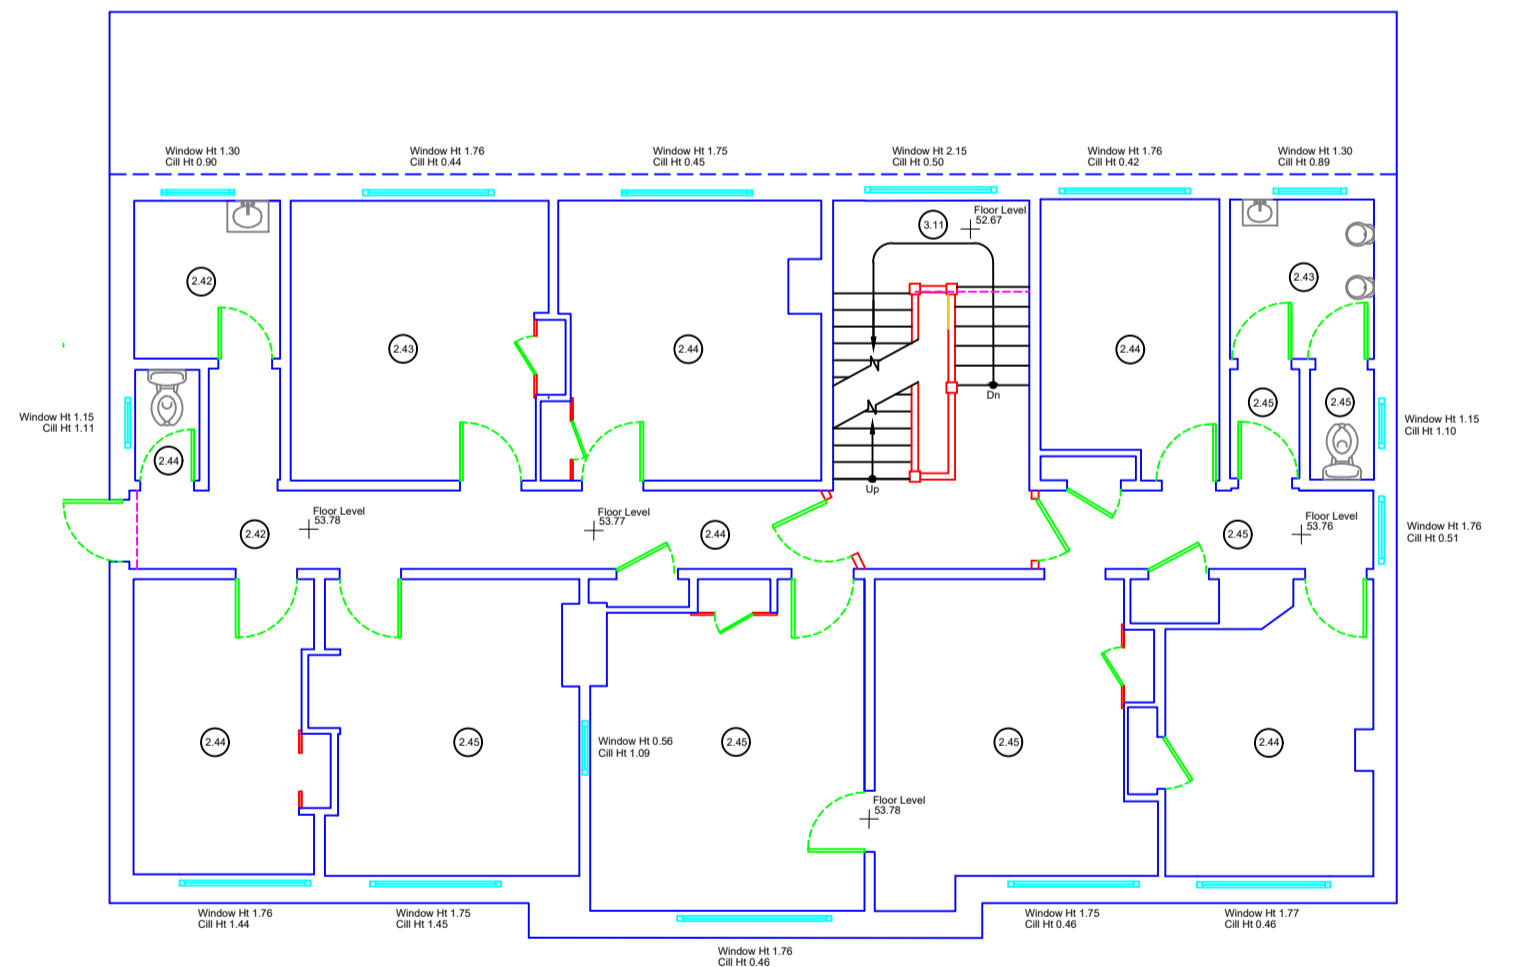

Block 1
Second Floor

